



SECTION A  
SCALE 1:50

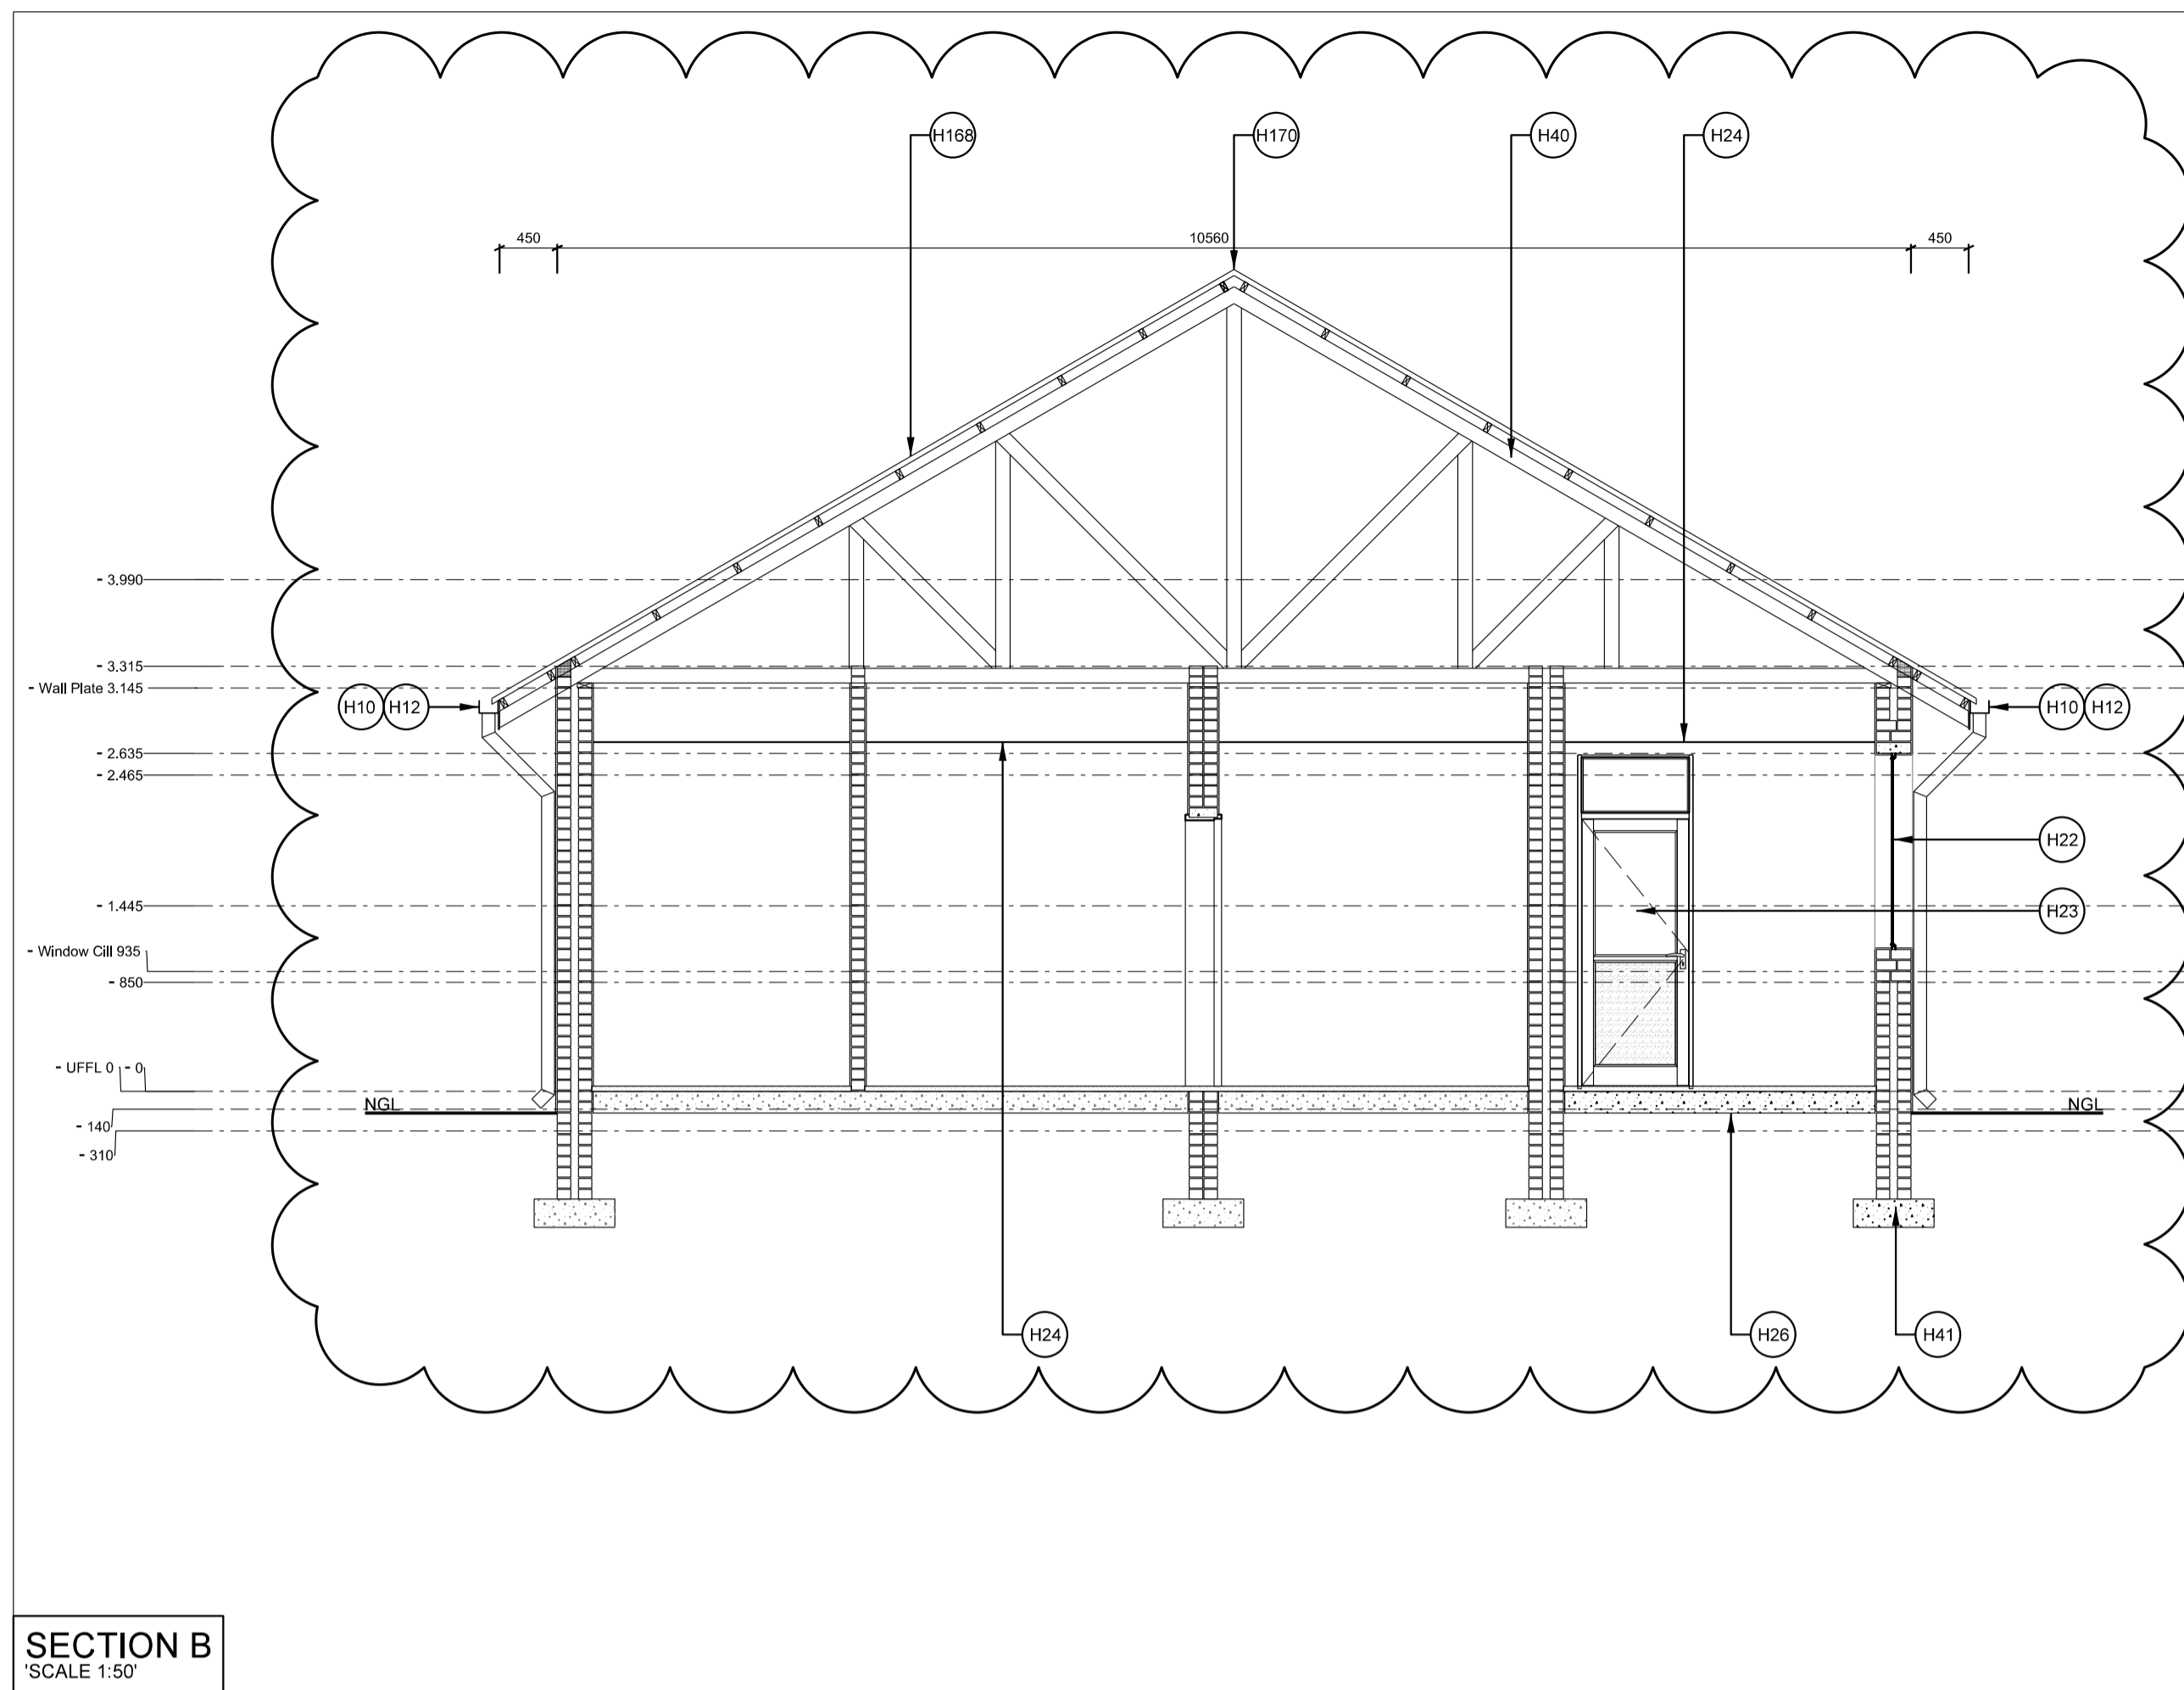

SECTION B  
SCALE 1:50

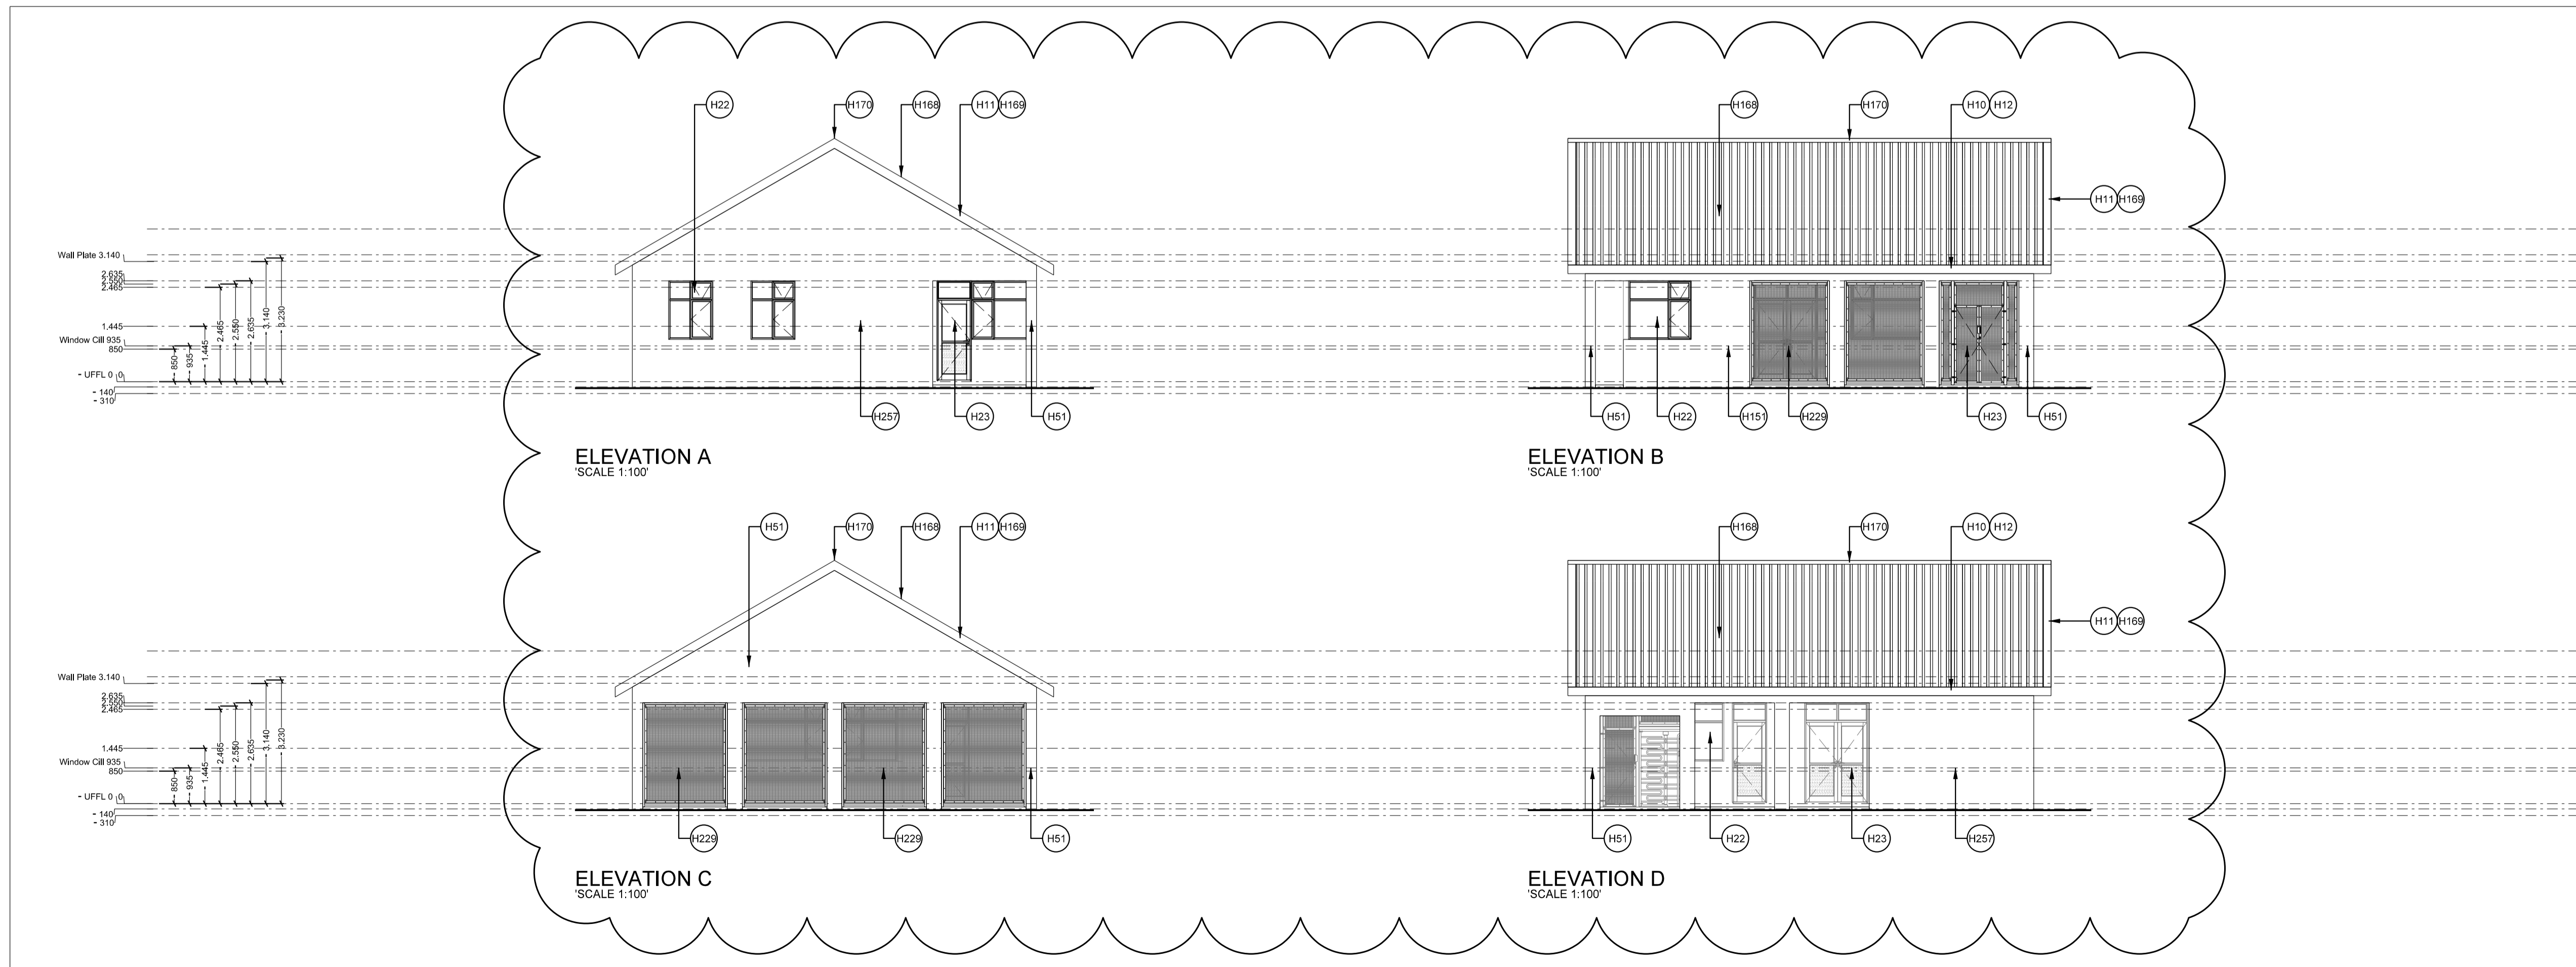

ELEVATION A  
SCALE 1:100

ELEVATION B  
SCALE 1:100

ELEVATION C  
SCALE 1:100

ELEVATION D  
SCALE 1:100

No.	DATE	AMENDMENT	D.P.W.
R01	2021-04-09	BV/S/ Revised according to changes on plan and roof plan	
R02	2021-04-21	BV/S/ Revised according to plan and roof plan	

Copyright vests in the Department of Public Works

as-built drawings

certified as-built drawings as per Centralised Drawing Archive AS-BUILT DRAWING REQUIREMENTS

name: \_\_\_\_\_

date: \_\_\_\_\_

professional registration no.: \_\_\_\_\_

cad file name	page type
25500-030-010	A 1

**public works**  
Department:  
Public Works  
REPUBLIC OF SOUTH AFRICA

DIRECTOR-GENERAL  
MR. MZIWONKE DLABANTU

consultant  
COPYRIGHT

**Bartsch**  
BARTSCH CONSULT (Pty) Ltd  
REG. NO. CK 903189523

HARRISMITH: TEL(051) 6223471, P.O.BOX 762, HARRISMITH 9690  
QUEENSTOWN: TEL(045) 839 5728, LADYSMITH: TEL(036) 631 1888  
EAST LONDON: TEL(043) 727 0765, BLOEMFONTEIN: TEL (051) 300547  
CAPE TOWN: TEL(021) 252225, PRETORIA: TEL(012) 3465526  
WINDHOEK : TEL(0926461) 237403.

discipline ARCHITECT

service

SKETCH PLANS

BERGVILLE JUSTICE - COMPLETE  
UPGRADING INCLUDING R & R

WCS number WCS 036745


drawing title  
GATE HOUSE SECTIONS  
AND ELEVATIONS


ref.no. \_\_\_\_\_ designed  
scale AS SHOWN drawn  
date 21-Apr-21 checked

DPW drawing number

25500-030-010 R02  
21-Apr-21



No.	DATE	AMENDMENT	D.P.W.
<small>10/1/2021-03/11/2021 Revised according to client request          10/2/2021-04/21/2021 Revised to include changes to gatehouse          10/2/2021-04/22/2021 Revised fence heights revised and final          references added.</small>			
Copyright vests in the Department of Public Works			
as-built drawings			
certified as-built drawings as per Centralised Drawing Archive AS-BUILT DRAWING REQUIREMENTS			
name: _____			
date: _____			
professional registration no.: _____			
cad file name		page type	
25500-000-100 A 0			
 <b>public works</b> Department of Public Works REPUBLIC OF SOUTH AFRICA DIRECTOR-GENERAL MR. NZIWOIKE DLABANTU			
consultant <b>Bartsch</b> BARTSCH CONSULT (Pty) Ltd REG. NO. DK 60788033 <small>HARRISBURGH: TEL:051 6224471 P.O. BOX 762 HARRISBURGH 5880          QUENSTOWN: TEL:033 5374 LADYSMITH: TEL:0359 831 1888          EAST LONDON: TEL:043 727 0765 BLOEMFONTEIN: TEL:051 300547          CAPE TOWN: TEL:021 323233 PRETORIA: TEL:011 300547          WINDHOEK: TEL:090554611 337403.</small>			
discipline ARCHITECT			
service SKETCH PLANS			
BERGVILLE JUSTICE - COMPLETE UPGRADING INCLUDING R & R			
WCS number		WCS 036745	
drawing title			
SITE PLAN			
ref.no.		designed	
scale		drawn BVS	
date		checked	
22-Apr-21			
DPW drawing number			
25500-000-100		R03 22-Apr-21	

 




REV: 2021-02-11 (R/1) Revised according to client request  
 REV: 2021-04-21 (R/2) Gatehouse plan revised to accommodate new roof structure.

Copyright vests in the Department of Public Works  
 as-built drawings  
 certified as-built drawings as per Centralised Drawing Archive AS-BUILT DRAWING REQUIREMENTS  
 name: \_\_\_\_\_  
 date: \_\_\_\_\_  
 professional registration no.: \_\_\_\_\_

cad file name: 25500-010-001 A 0 page type

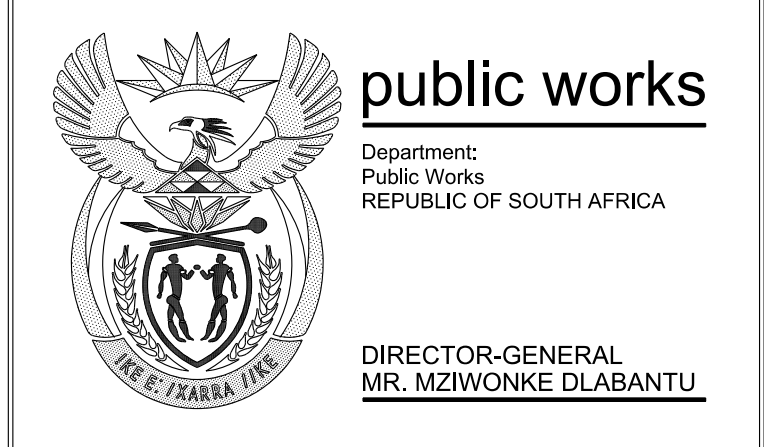

consultant: **Bartsch**  
 BARTSCH CONSULT (Pty) Ltd  
 REG. NO. DK 60788023  
 HARRISBURGH: TEL: 051 822471 P.O. BOX 782 HARRISBURGH 5880  
 QUENSTOWN: TEL: 033 5724 LADYSMITH: TEL: 0333 831 188  
 EAST LONDON: TEL: 031 727 0765 BLOEMFONTEIN: TEL: 051 300547  
 CAPE TOWN: TEL: 021 333 3333 PRETORIA: TEL: 011 3460547  
 WINDHOEK: TEL: 090554611 337403

discipline: ARCHITECT  
 service: \_\_\_\_\_




**BERGVILLE JUSTICE - COMPLETE UPGRADING INCLUDING R & R**

WCS number: WCS 036745  
 drawing title: COMPLEX PLAN




ref. no.	designed
scale	1:100
date	21-Apr-21
DPW drawing number	25500-010-001

R02  
 21-Apr-21

WALL LEGEND	
	LOW LEVEL WALL
	NEW BRICK WALLS
	EXISTING WALL
	DEMOLISH EXISTING

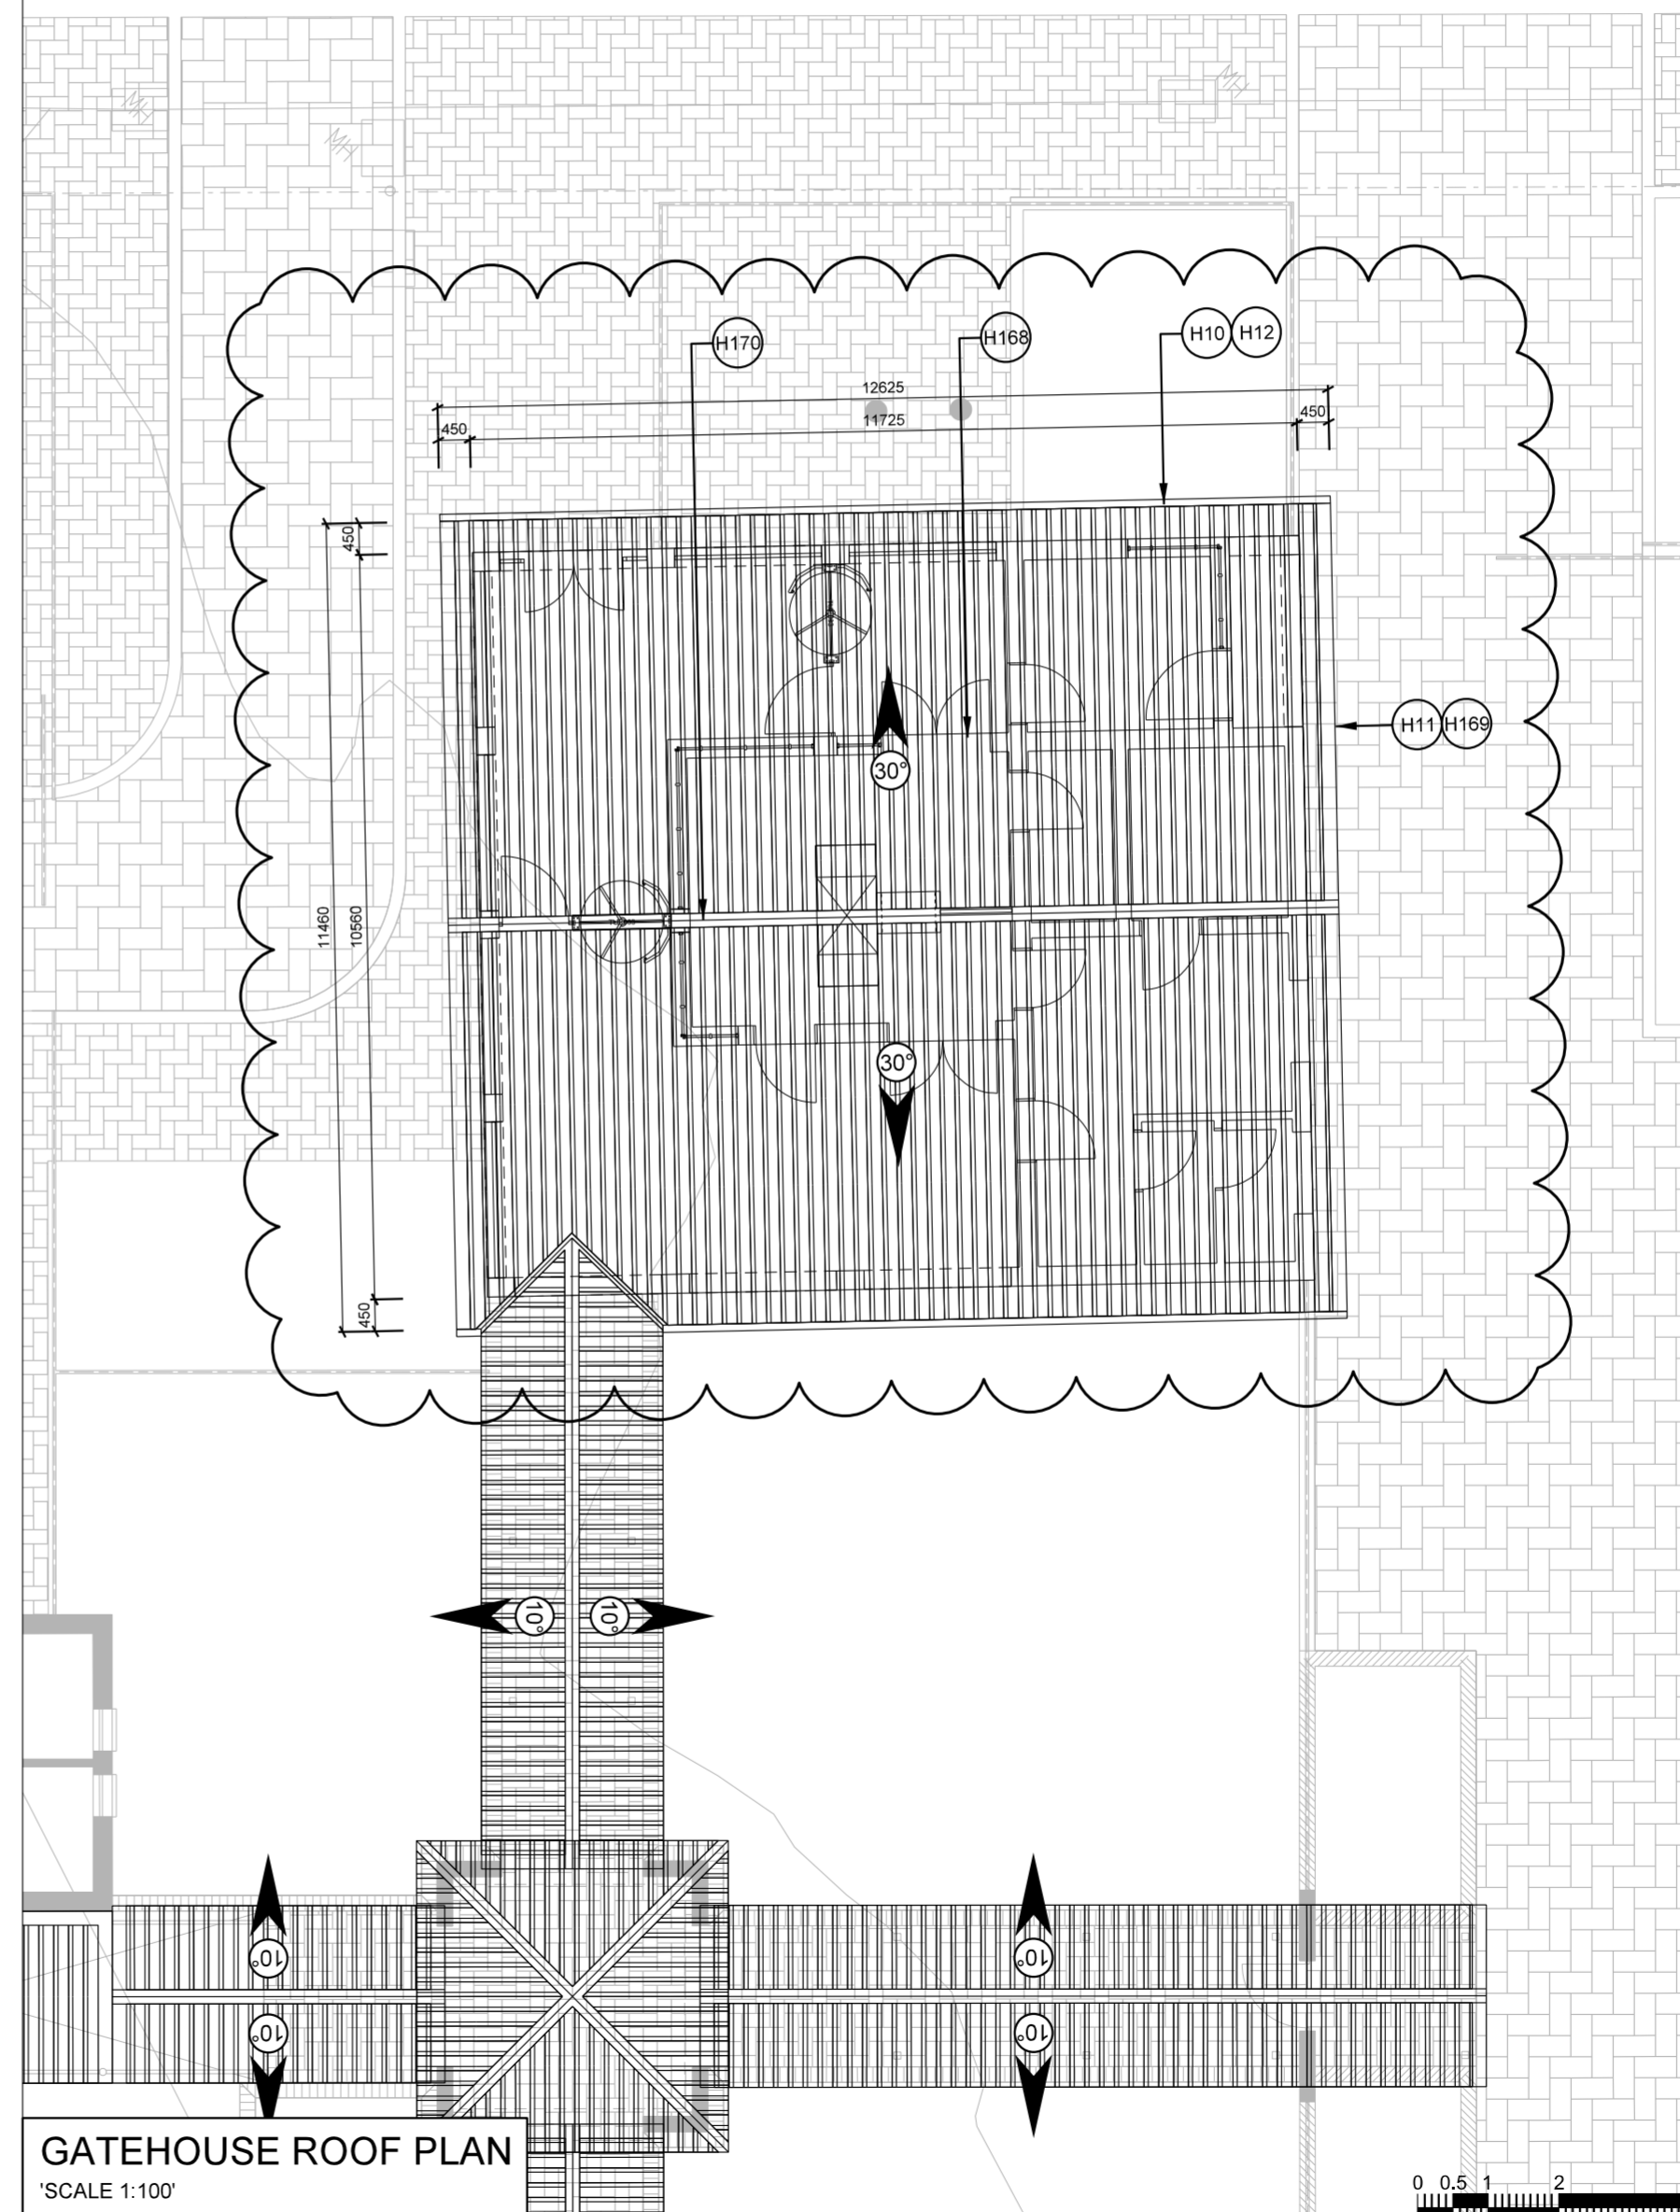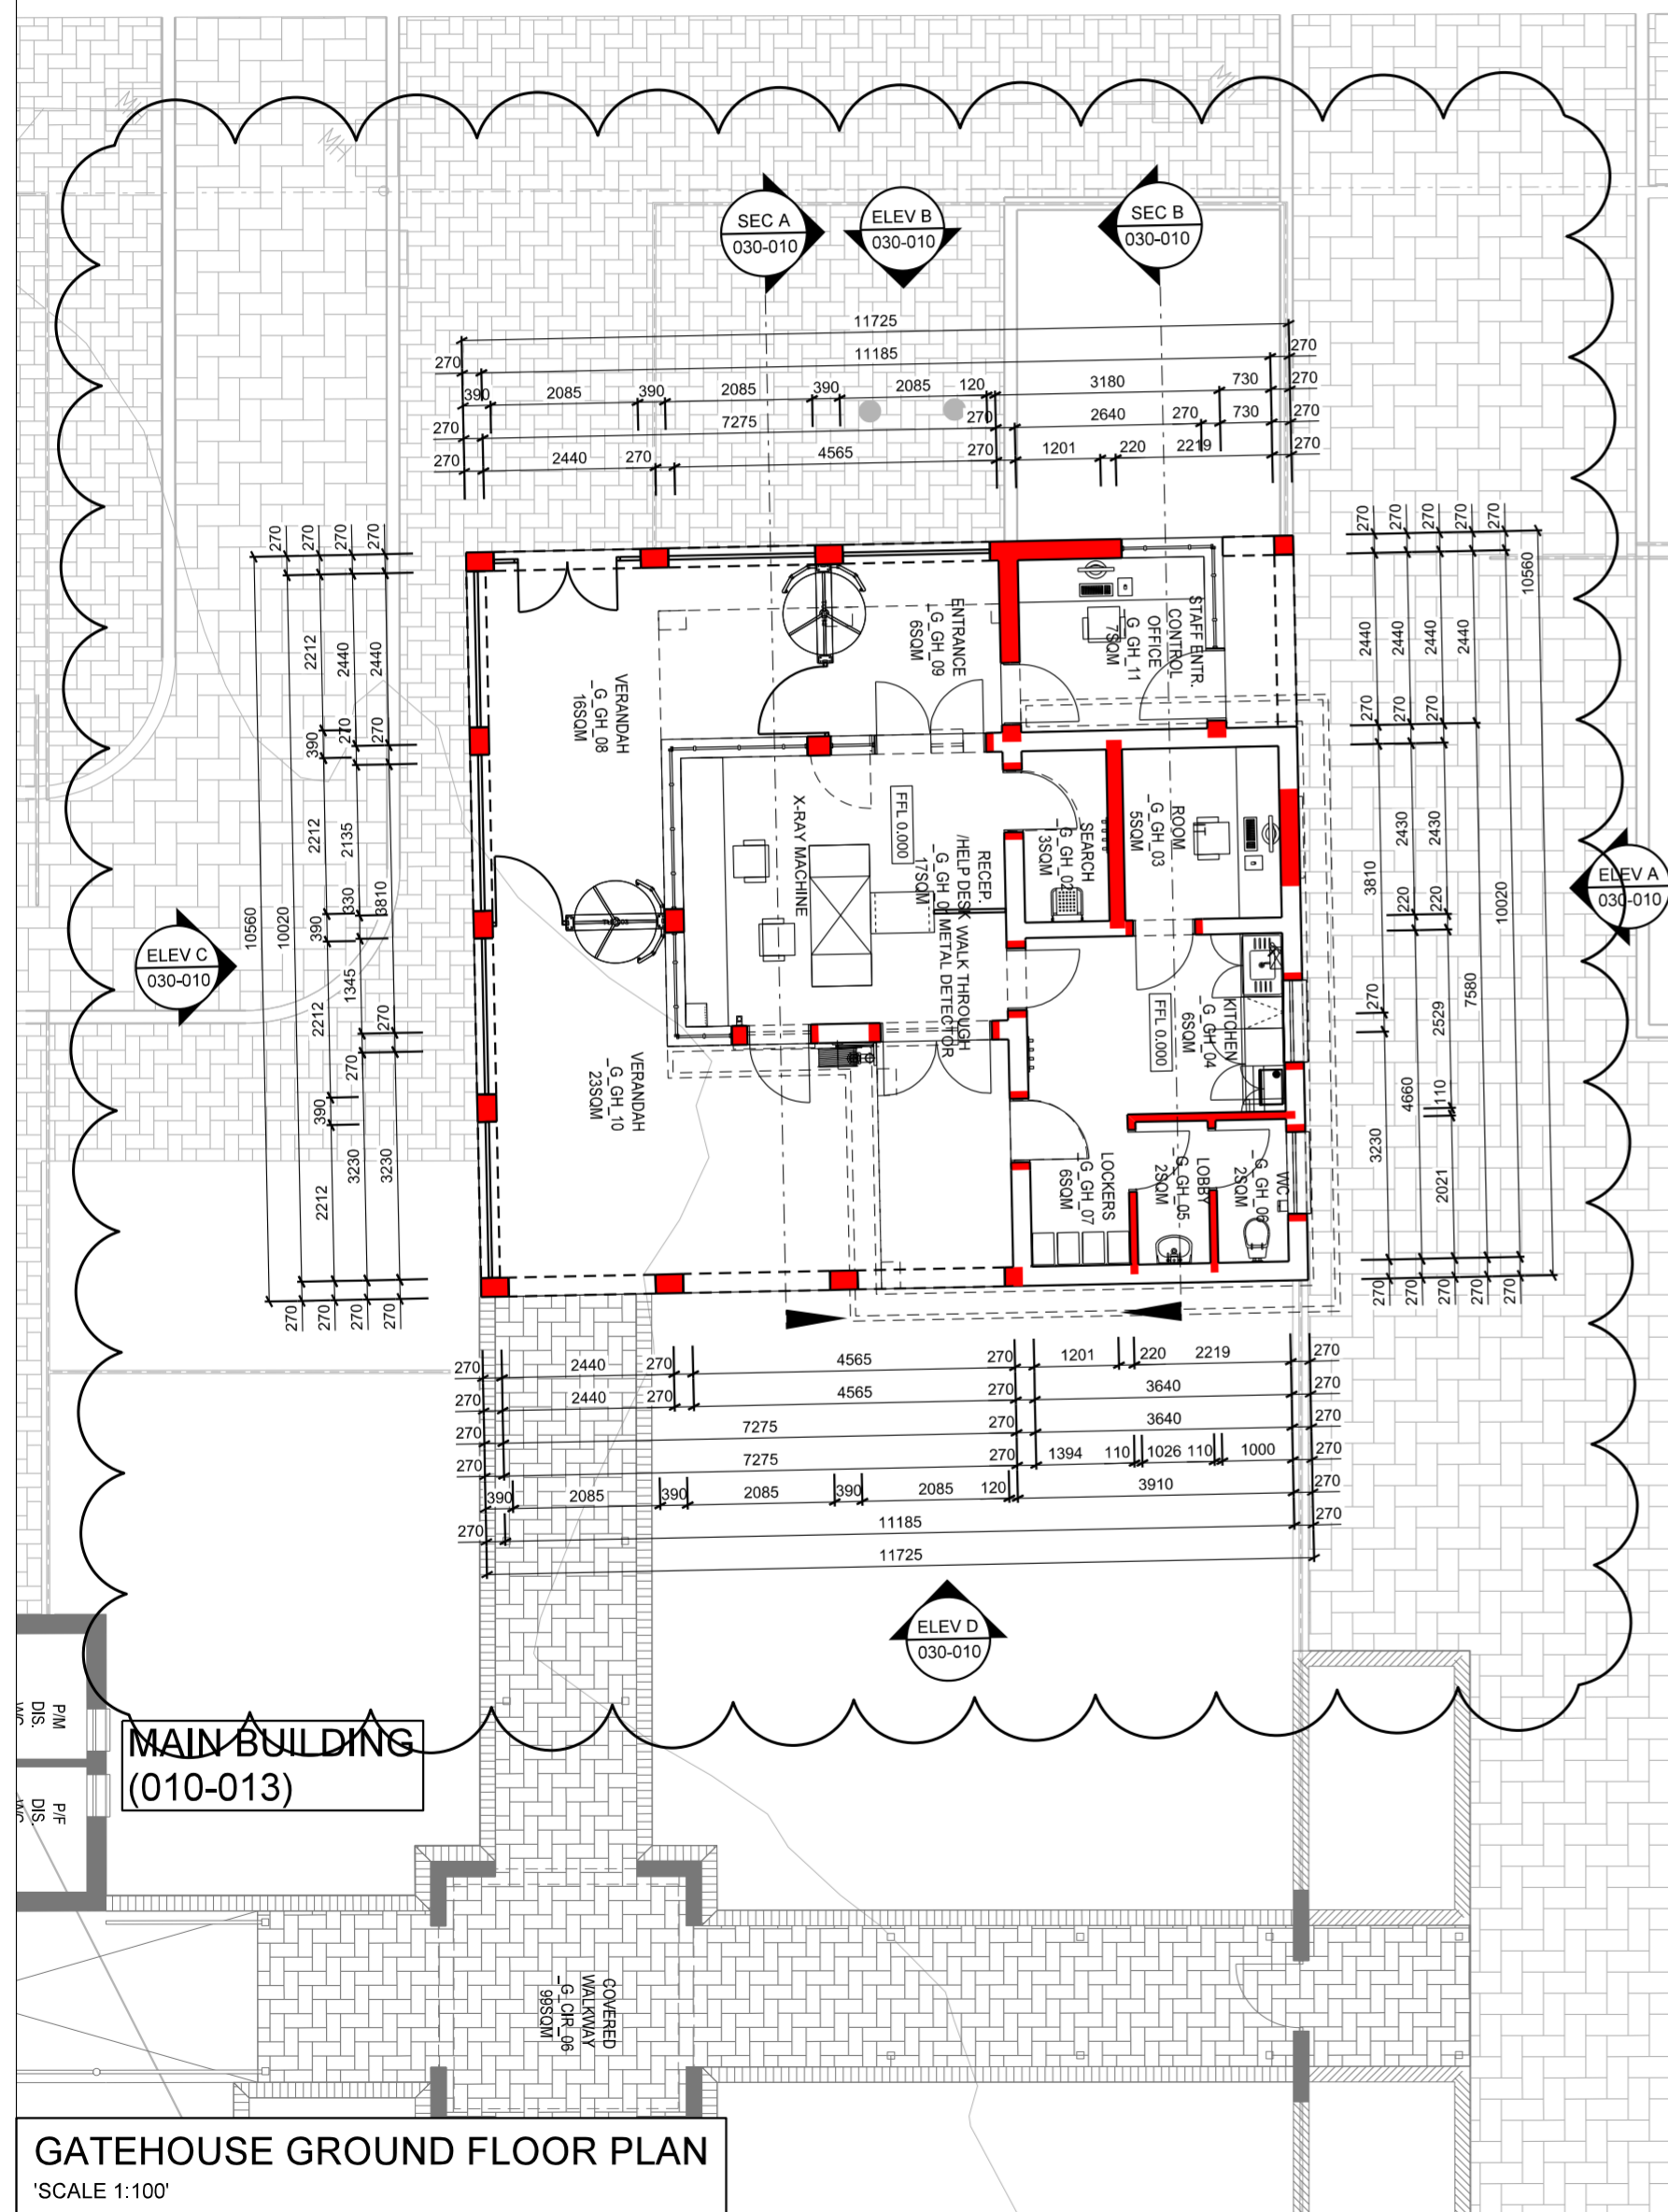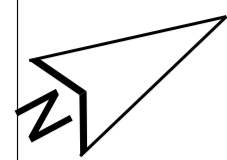


No.	DATE	AMENDMENT	D.P.W.
<small>*R01/ 2013/03/01/ FJP/ AD DETAILS REFERENCES.            R02/ 2013/12/04/ MFT/ Dimensions added on the canopy columns on plan and canopy roof updated.            R03/ 2014-02-11/ KvD/ Update column spacing for roof overhang to be equal both sides.            R04/ 2014-04-09/ BVS/ Revised as per client specifications.            R05/ 2014-04-21/ BVS/ Plan revised to accommodate new roof. Roof plan revised to include new roof and link to walkway.</small>			
PLAN LEGEND			
	- EXISTING WALL		
	- NEW WALL		
	- WALL TO BE DEMOLISHED		
Copyright vests in the Department of Public Works			
as-built drawings			
certified as-built drawings as per Centralised Drawing Archive AS-BUILT DRAWING REQUIREMENTS			
name: _____			
date: _____			
professional registration no.: _____			
cad file name		page type	
25500-010-010		A 2	
<b>public works</b> <small>Department: Public Works          REPUBLIC OF SOUTH AFRICA</small>			
<small>DIRECTOR-GENERAL          MR. MZIWONKE DLABANTU</small>			
consultant			
discipline			
ARCHITECT			
service			
SKETCH PLANS			
BERGVILLE JUSTICE - COMPLETE UPGRADING INCLUDING R & R			
WCS number		WCS 036745	
drawing title			
GATEHOUSE - PLAN			
ref.no.	designed		
scale	1:100	drawn	BVS
date	21-Apr-21	checked	
DPW drawing number			
25500-010-010		R05 21-Apr-21	

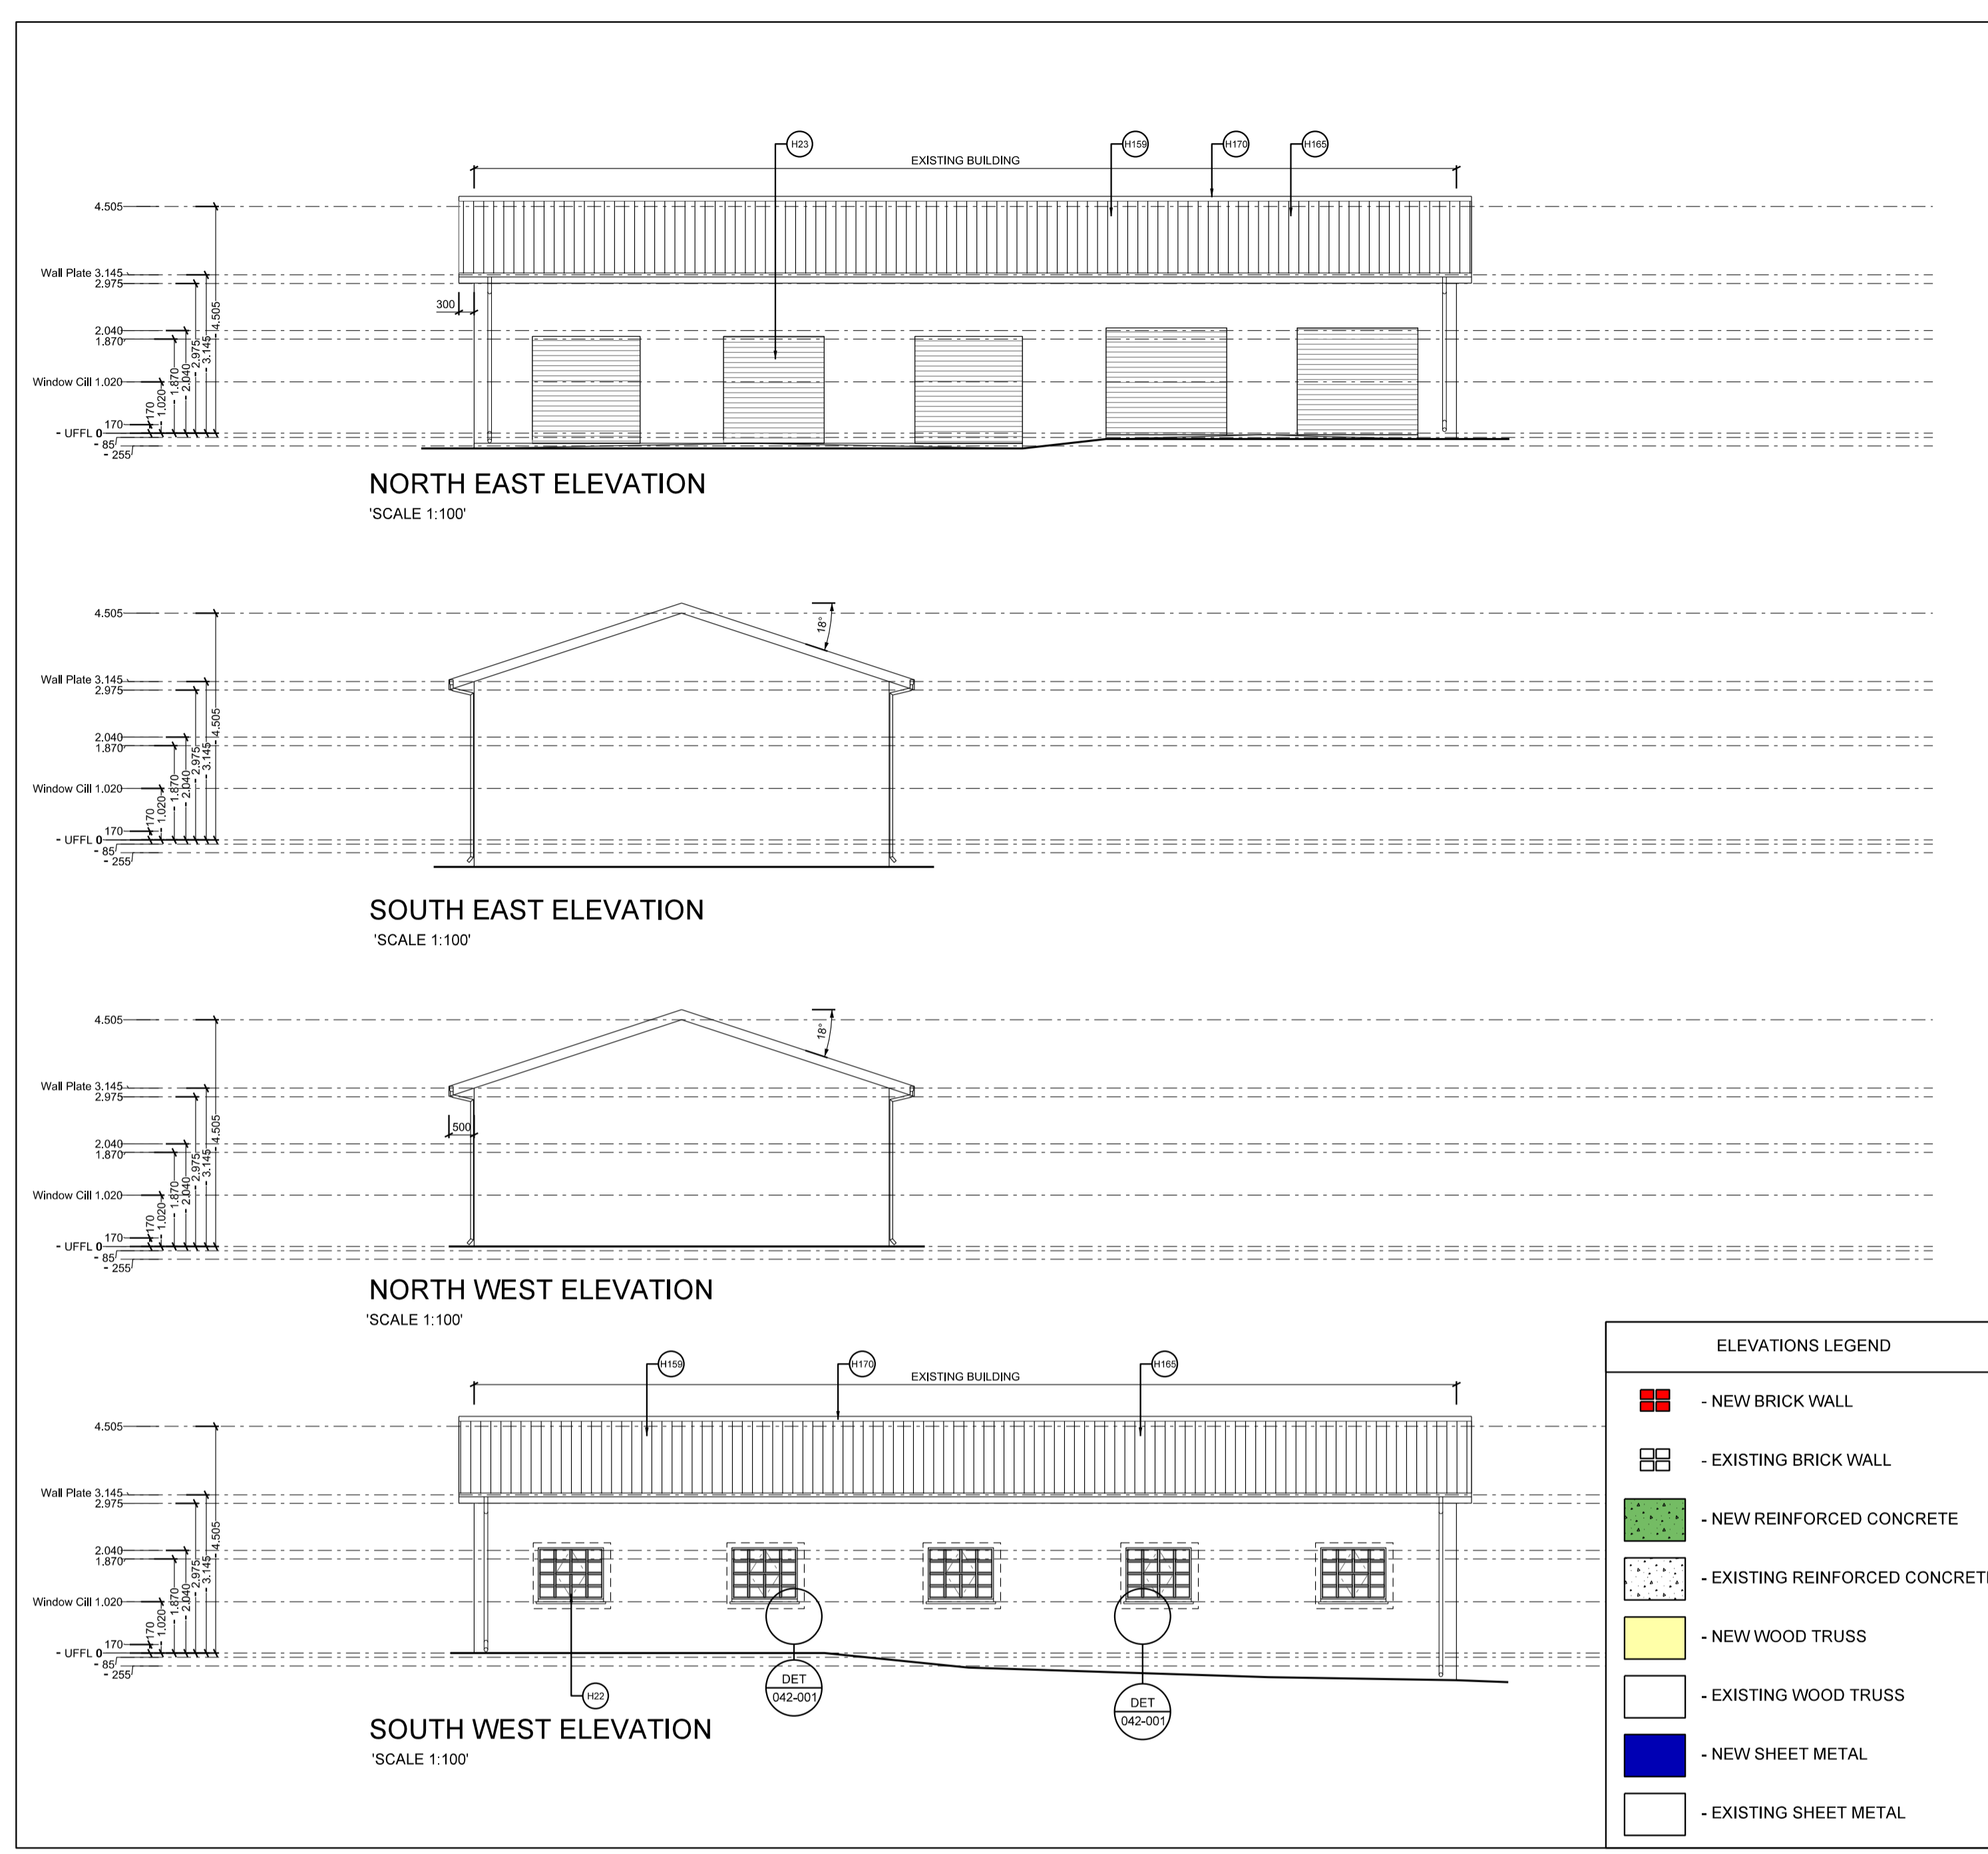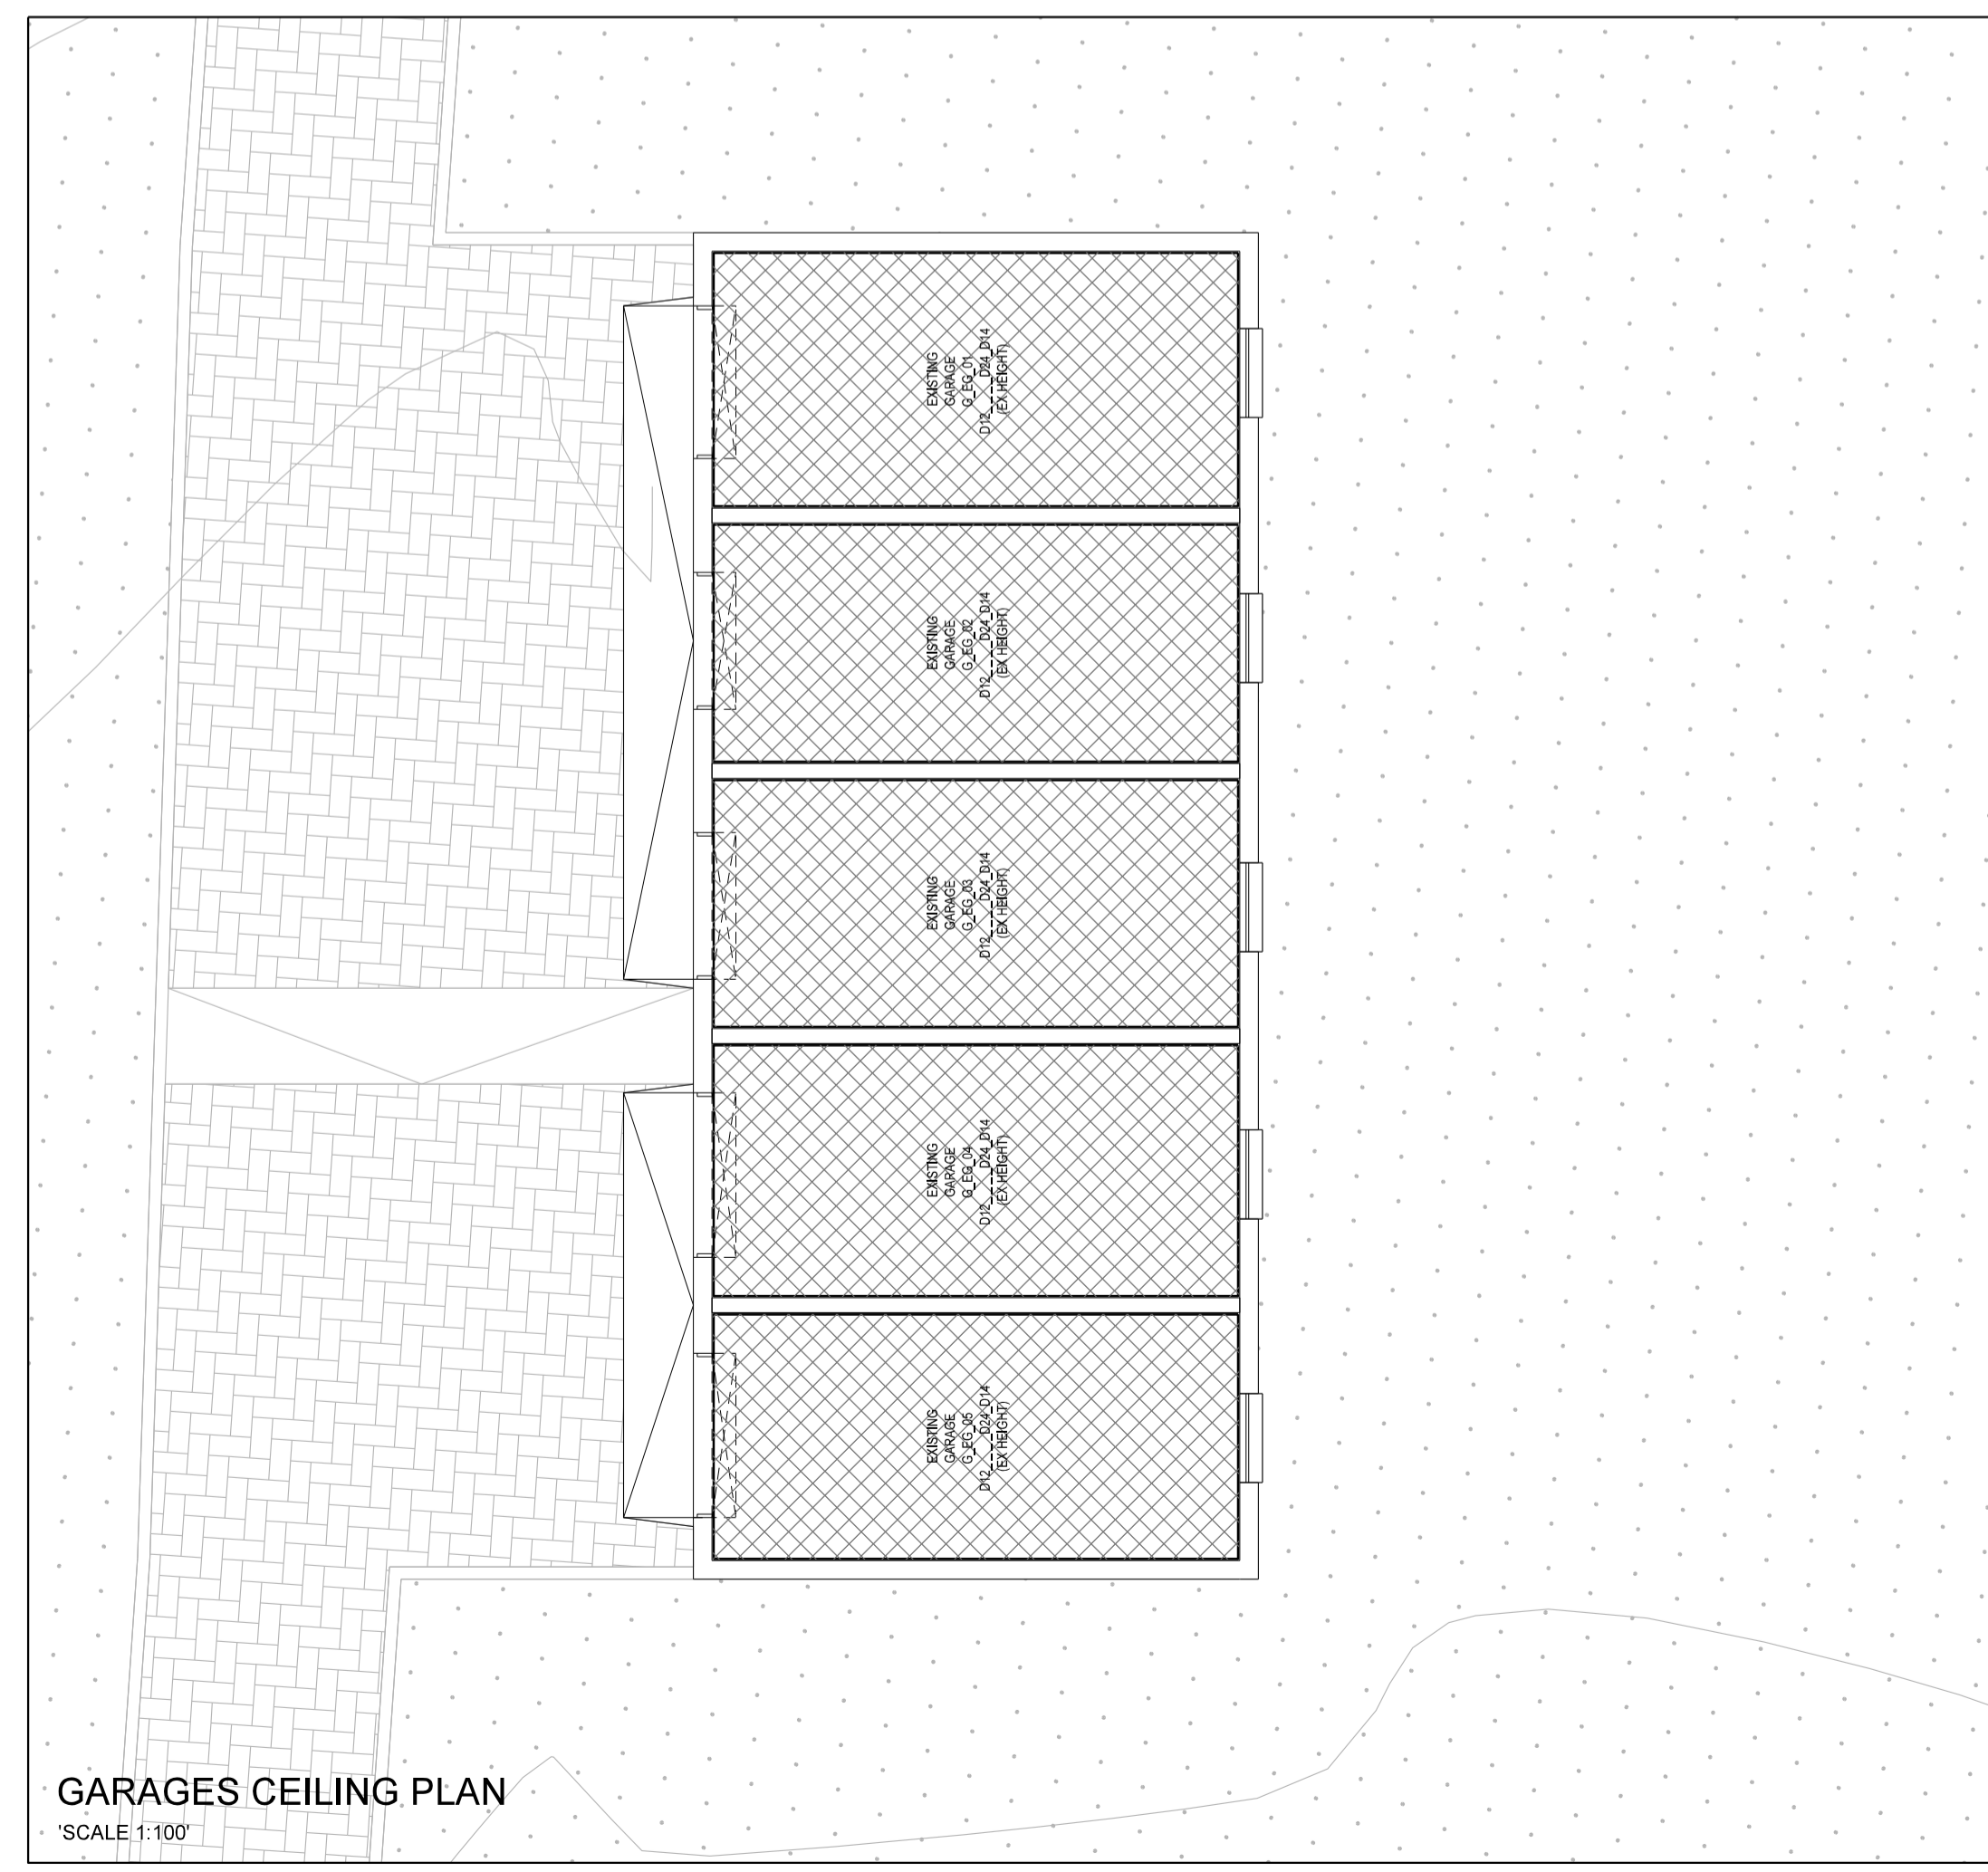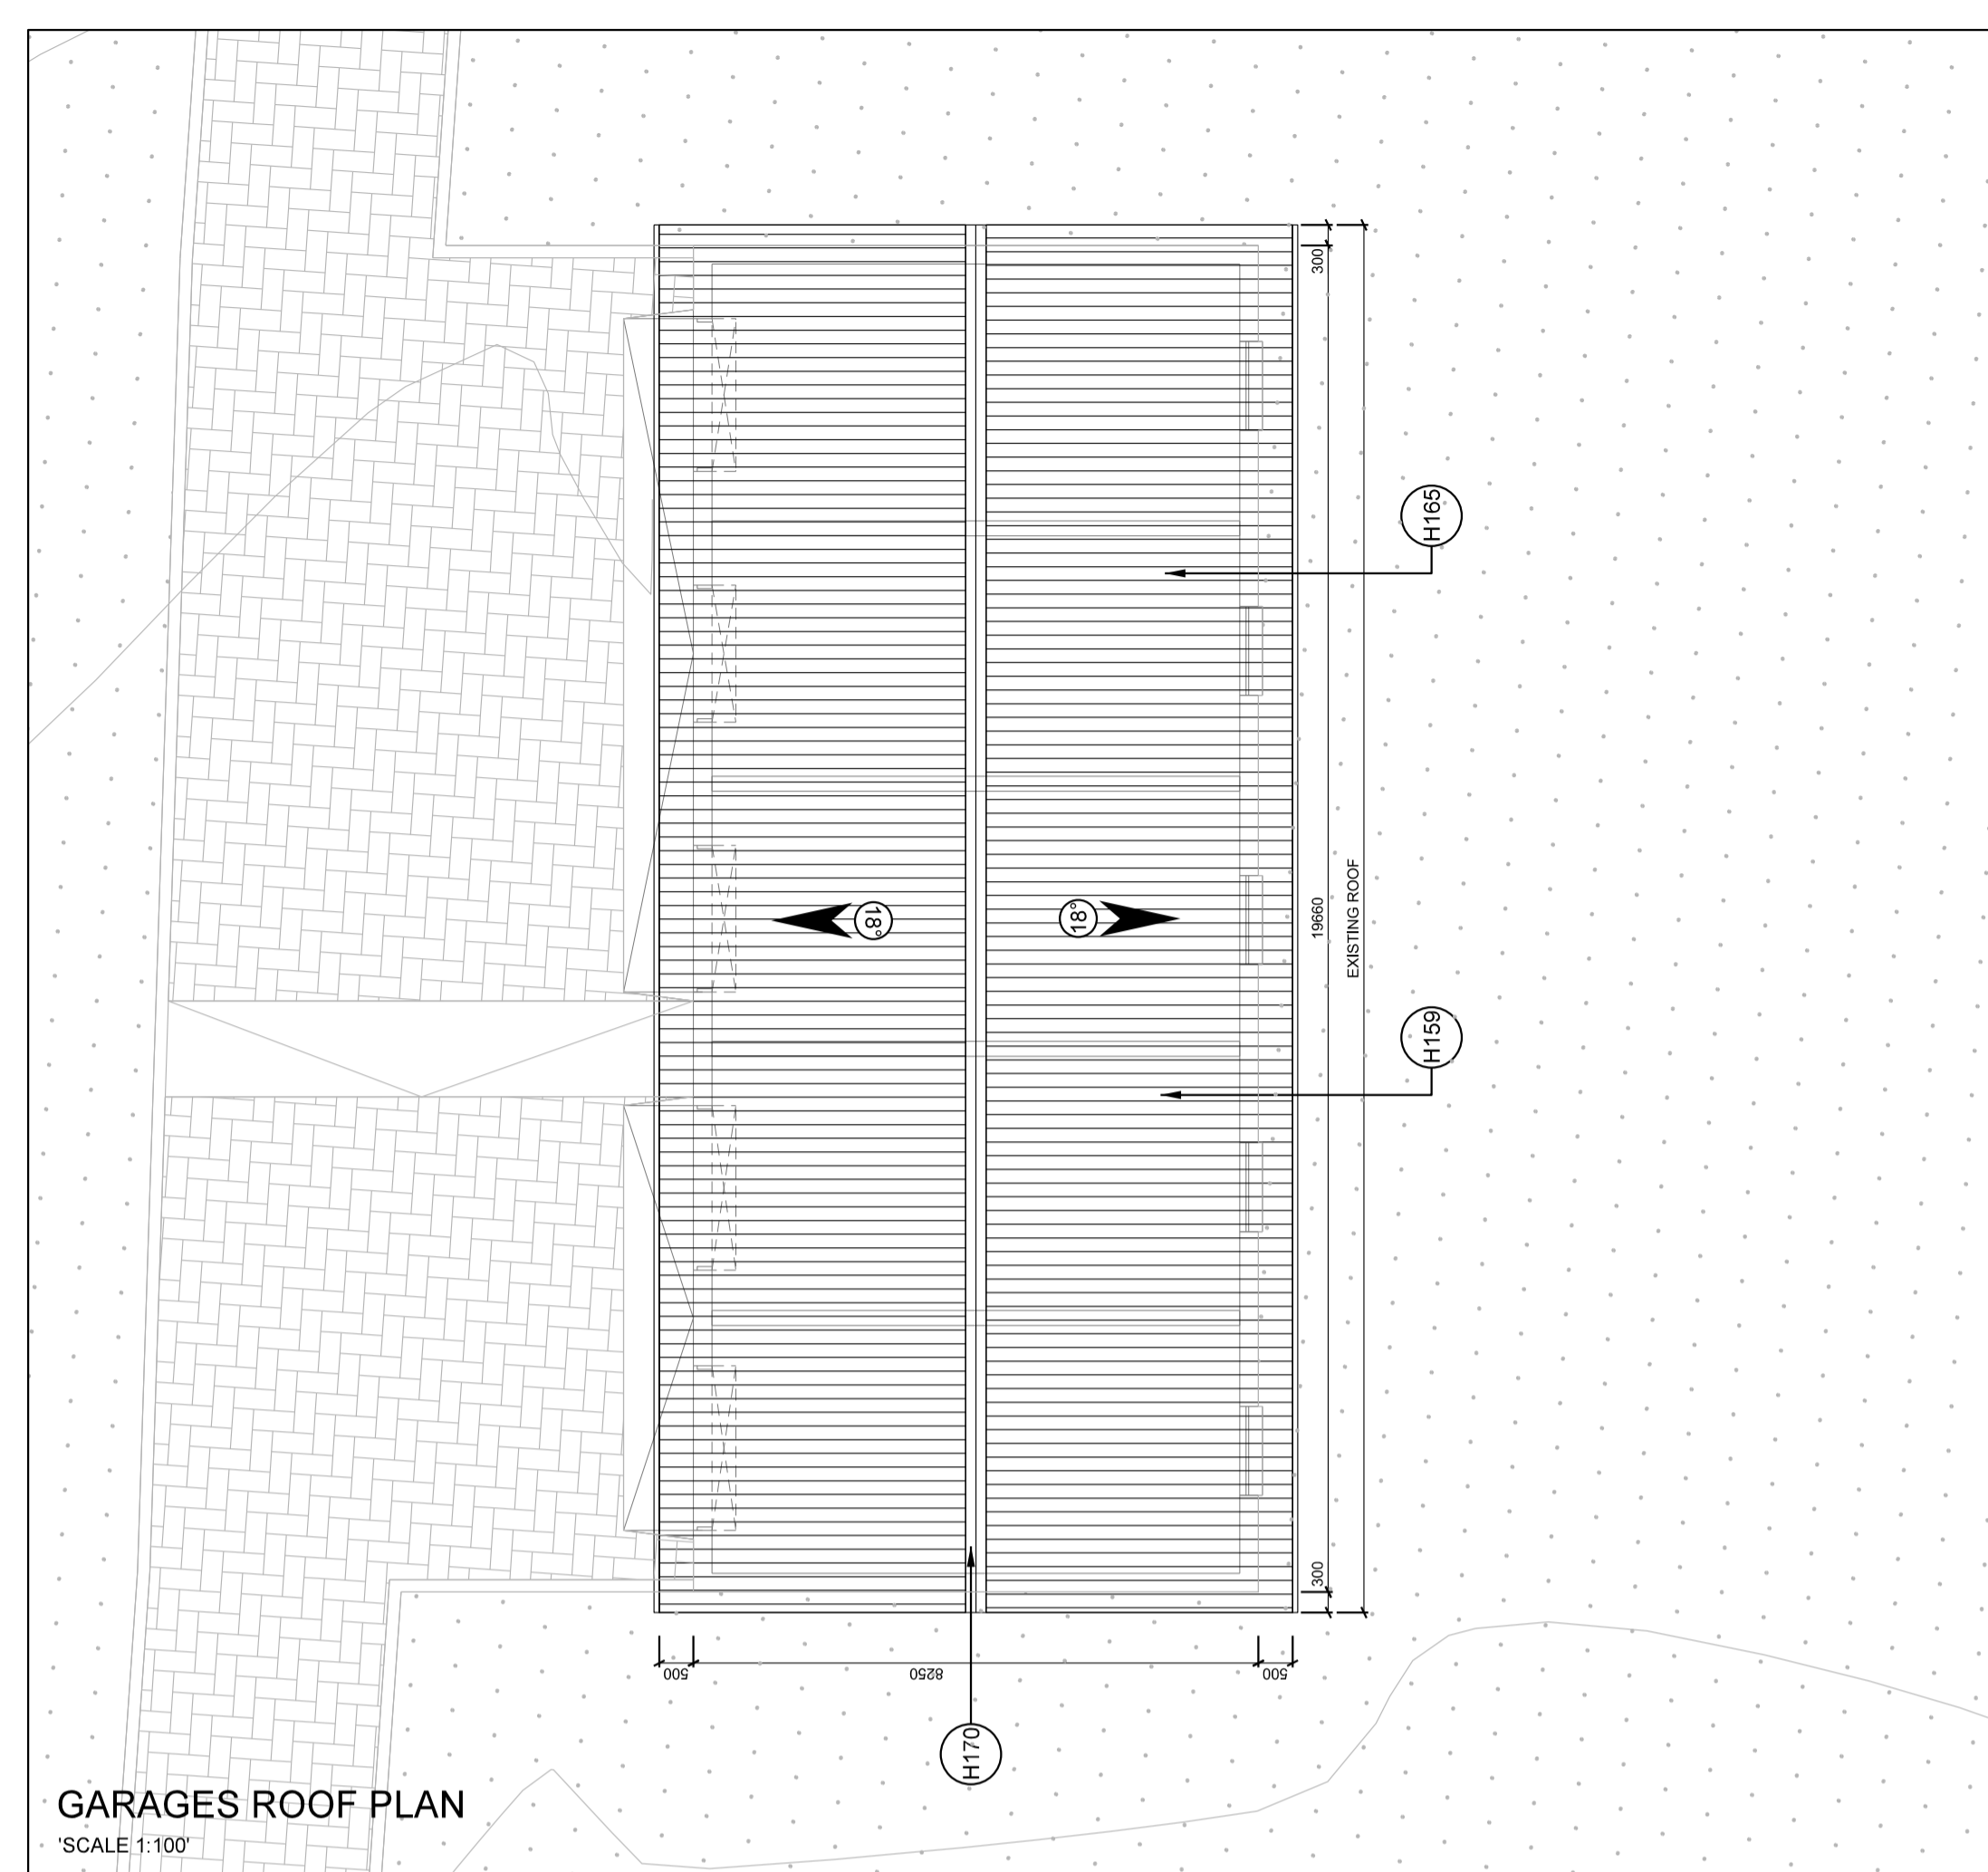

**ELEVATIONS LEGEND**

- NEW BRICK WALL
- EXISTING BRICK WALL
- NEW REINFORCED CONCRETE
- EXISTING REINFORCED CONCRETE
- NEW WOOD TRUSS
- EXISTING WOOD TRUSS
- NEW SHEET METAL
- EXISTING SHEET METAL

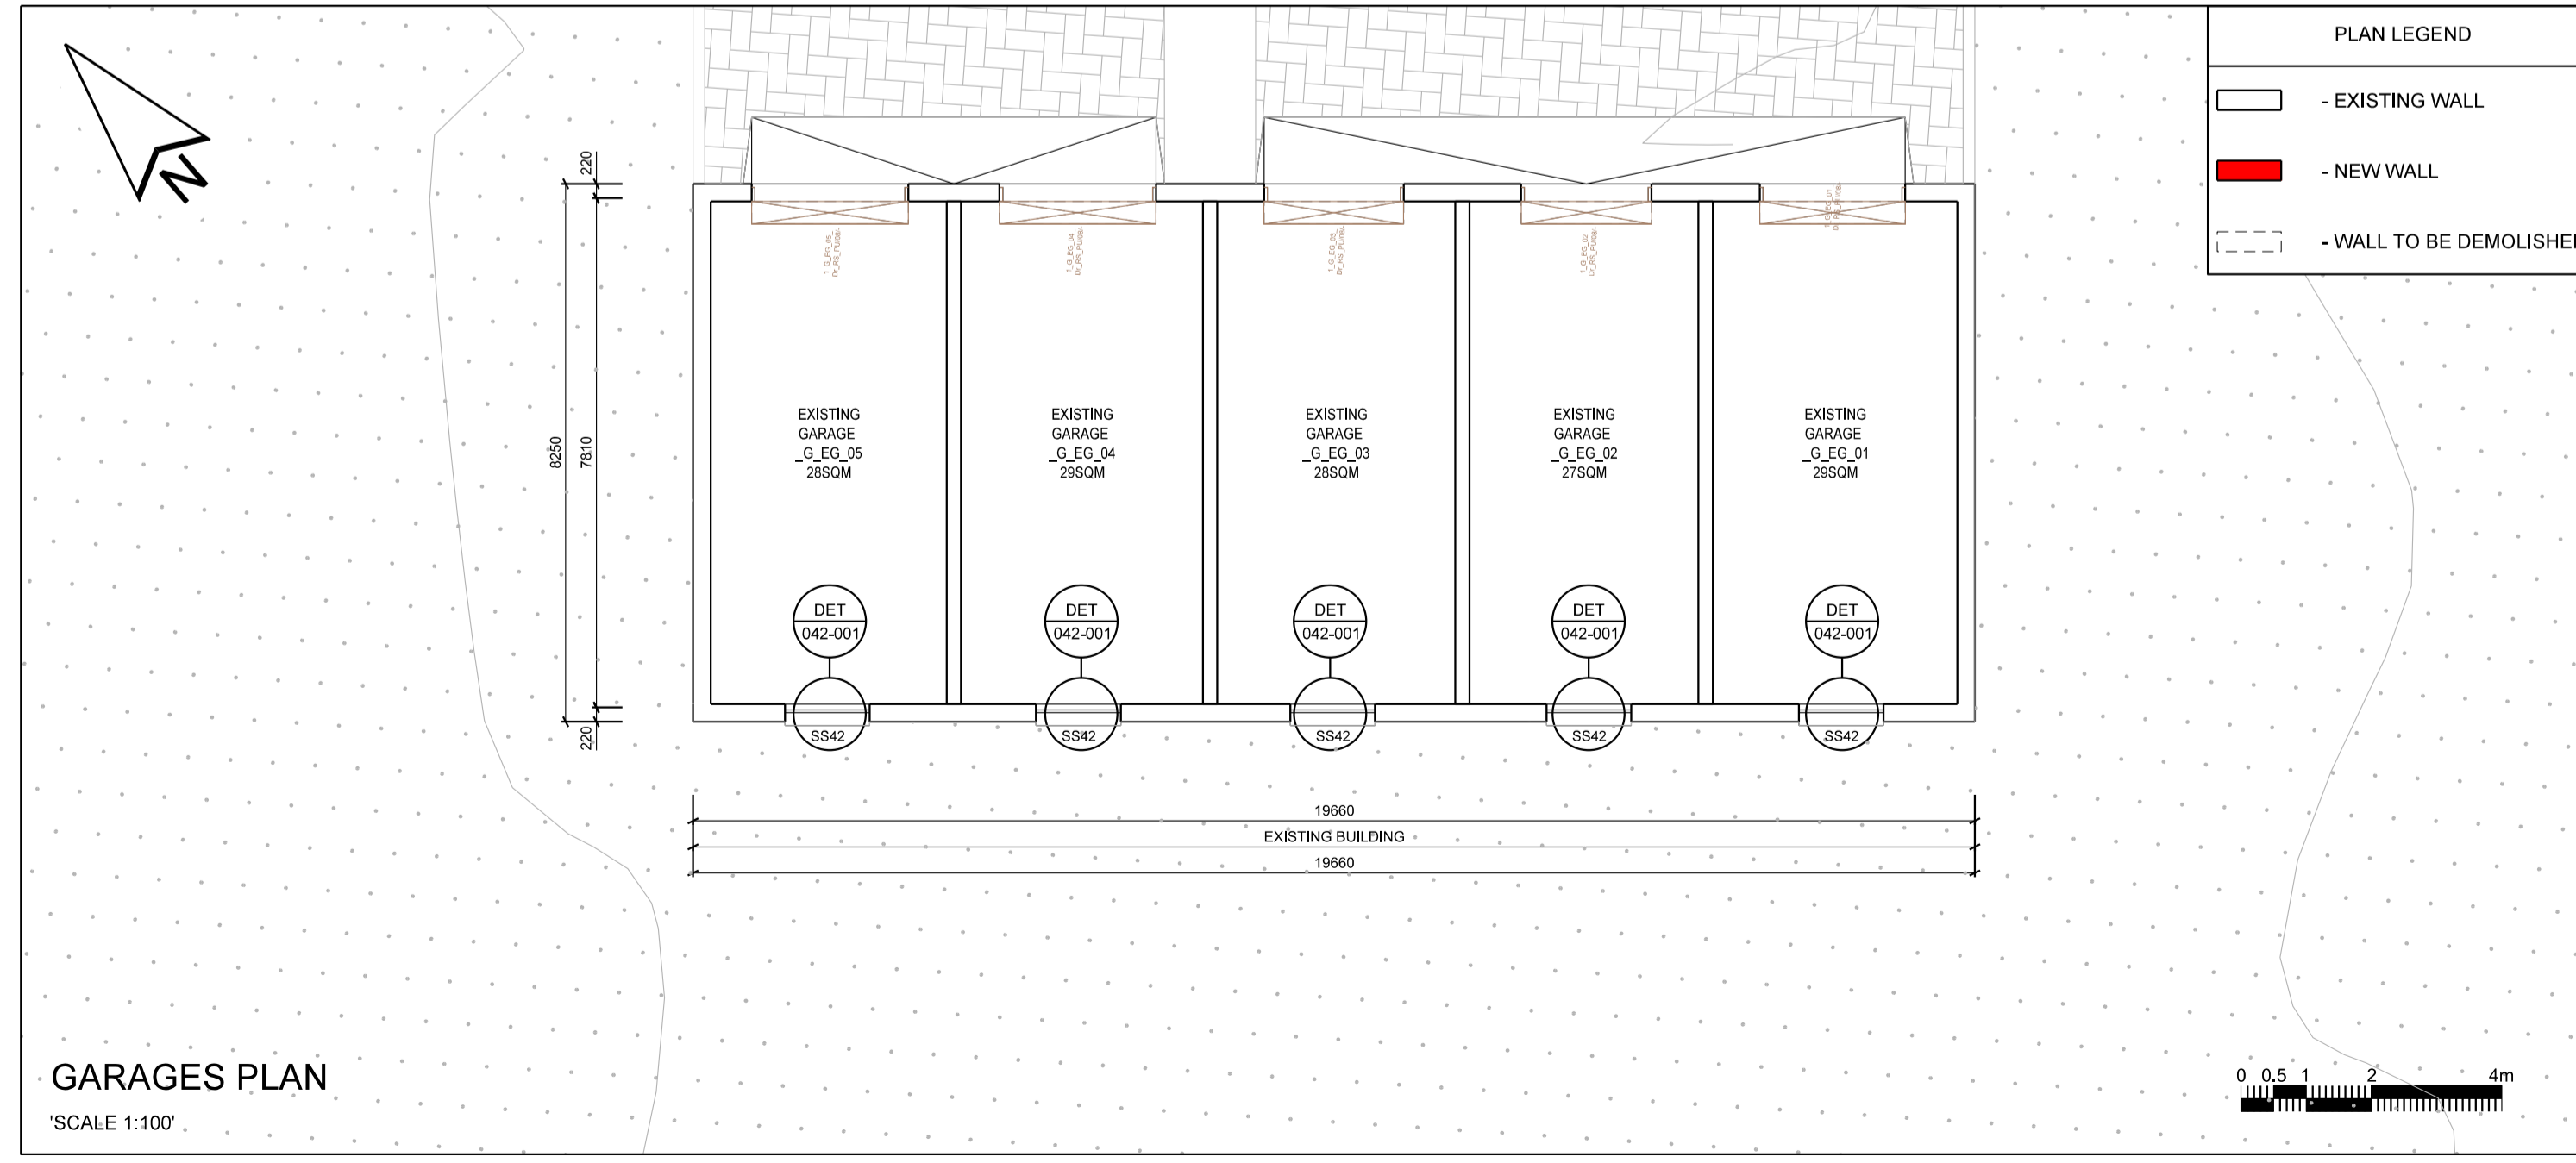

No.	DATE	AMENDMENT	D.P.W.
R01	2013/03/01	FJP/ AD DETAIL REFERENCES	
R02	2013-10-29	KvB/ Add bird proof mesh box detail	
R03	2019/11/15	BVS/ New garage extension omitted	
R04	2021-04-22	BVS/ Revised to include ceiling plan.	

Copyright vests in the Department of Public Works  
as-built drawings  
certified as-built drawings as per Centralised Drawing Archive AS-BUILT DRAWING REQUIREMENTS

name: \_\_\_\_\_  
date: \_\_\_\_\_  
professional registration no.: \_\_\_\_\_

cad file name: 25500-010-011 page type: A 1

**public works**  
Department: Public Works  
REPUBLIC OF SOUTH AFRICA

**DIRECTOR-GENERAL**  
MR. MZIWONKE DLABANTU

consultant: Bartsch  
BARTSCH CONSULT (Pty) Ltd  
REG. NO. CK 903189523

HARRISMITH: TEL(051) 5223471, P.O.BOX 762, HARRISMITH 9690  
QUEENSTOWN: TEL(045) 839 5728, LADYSMITH: TEL(036) 631 1888  
EAST LONDON: TEL(043) 727 0765, BLOEMFONTEIN: TEL (051) 300547  
CAPE TOWN: TEL(021) 252225, PRETORIA: TEL(012) 3465526  
WINDHOEK : TEL(0926461) 237403.

discipline: ARCHITECT  
service: \_\_\_\_\_

**SKETCH PLANS**

**BERGVILLE JUSTICE - COMPLETE UPGRADING INCLUDING R & R**

WCS number: \_\_\_\_\_  
drawing title: WCS 036745  
"GARAGES - PLAN, ELEVATIONS, SECTION, CEILING AND ROOF PLAN"

ref.no. \_\_\_\_\_ designed \_\_\_\_\_  
scale: 1:100 drawn: BVS  
date: 22-Apr-21 checked \_\_\_\_\_  
DPW drawing number: \_\_\_\_\_

**25500-010-011** R04  
22-Apr-21