



COLOUR	No.	AREA	SIZE	CLIENT	CHAIRS	FABLES	TOILETS
					PLASTIC	BANQUET	OTHER
+	A1	PROCESsing HALL	4m x 4m	BUS			10
		PROCESsing HALL	40m x 20m	Home Affairs	75	25	6

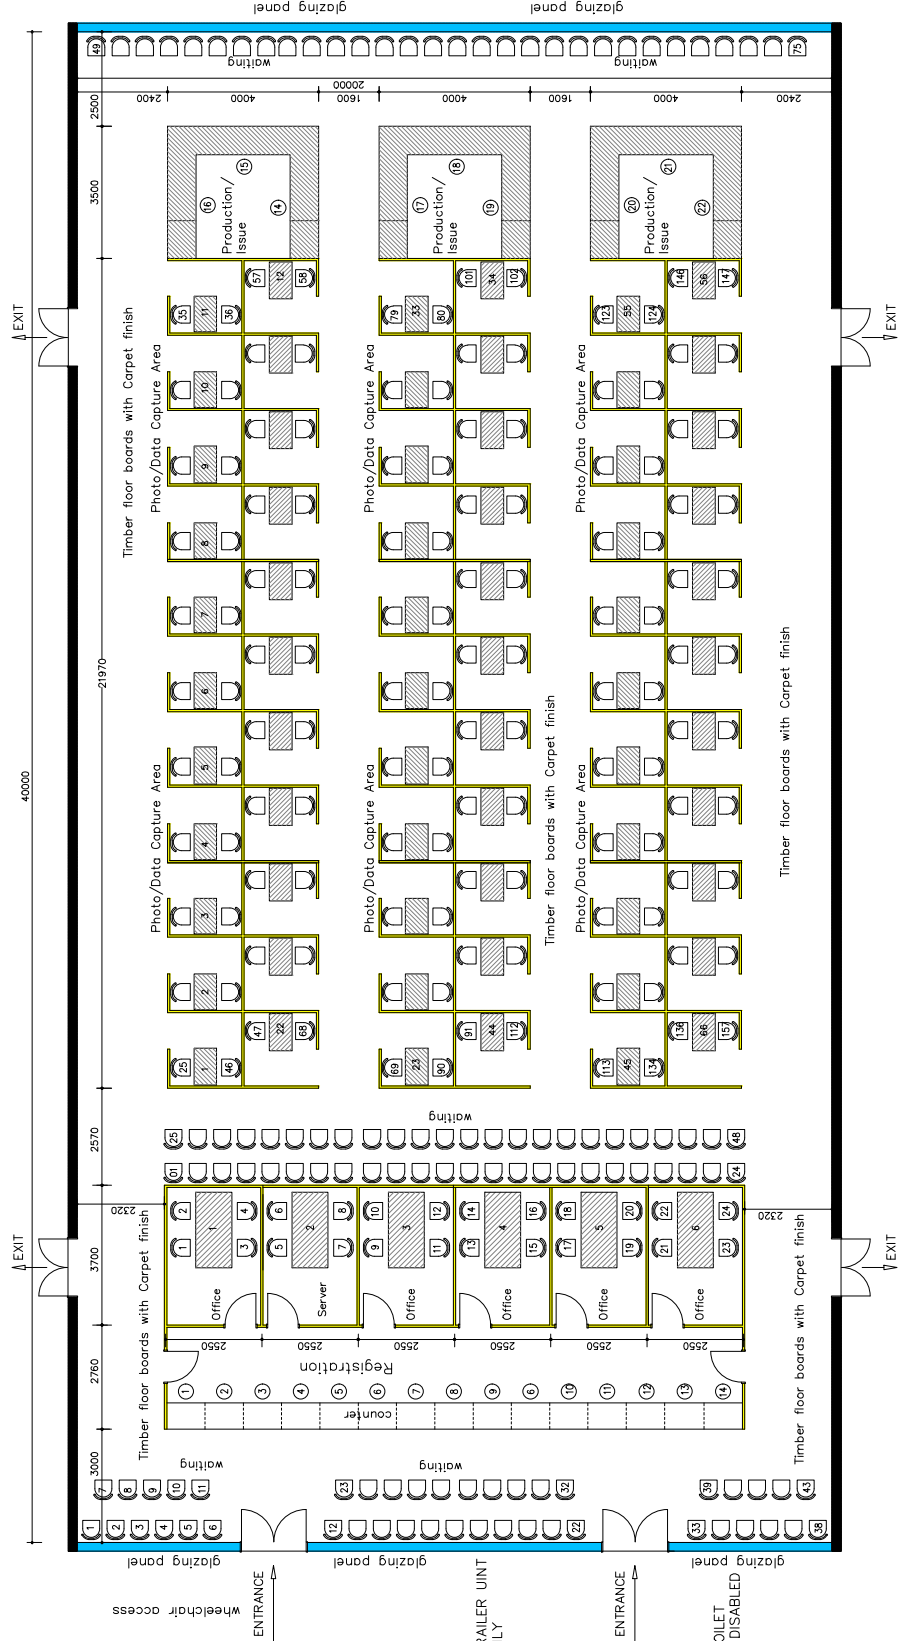

PROCESSING CENTRE x 3
Scale 1:50

Note: All dimensions to be checked on site, before commencing with any work

CONFIDENTIAL

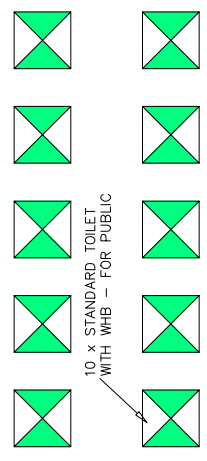

EMS: PARKING FOR AMBULANCE



DATE	DESCRIPTION

Project No: A0
Drawing No: 24-201702-3



DEPARTMENTAL ARCHITECTURAL
Department of Public Works and Infrastructure
Strategic Procurement Centre

WCS: N/A
GROUND FLOOR PLAN
Scale: 1:50
Drawing No: 24-201702-3
Project No: A0